


S:\data\30014837\CAO\PROCESS\BUILDING HVAC P&ID.dwg, 05/15/09 @ 16:47 opas@ls

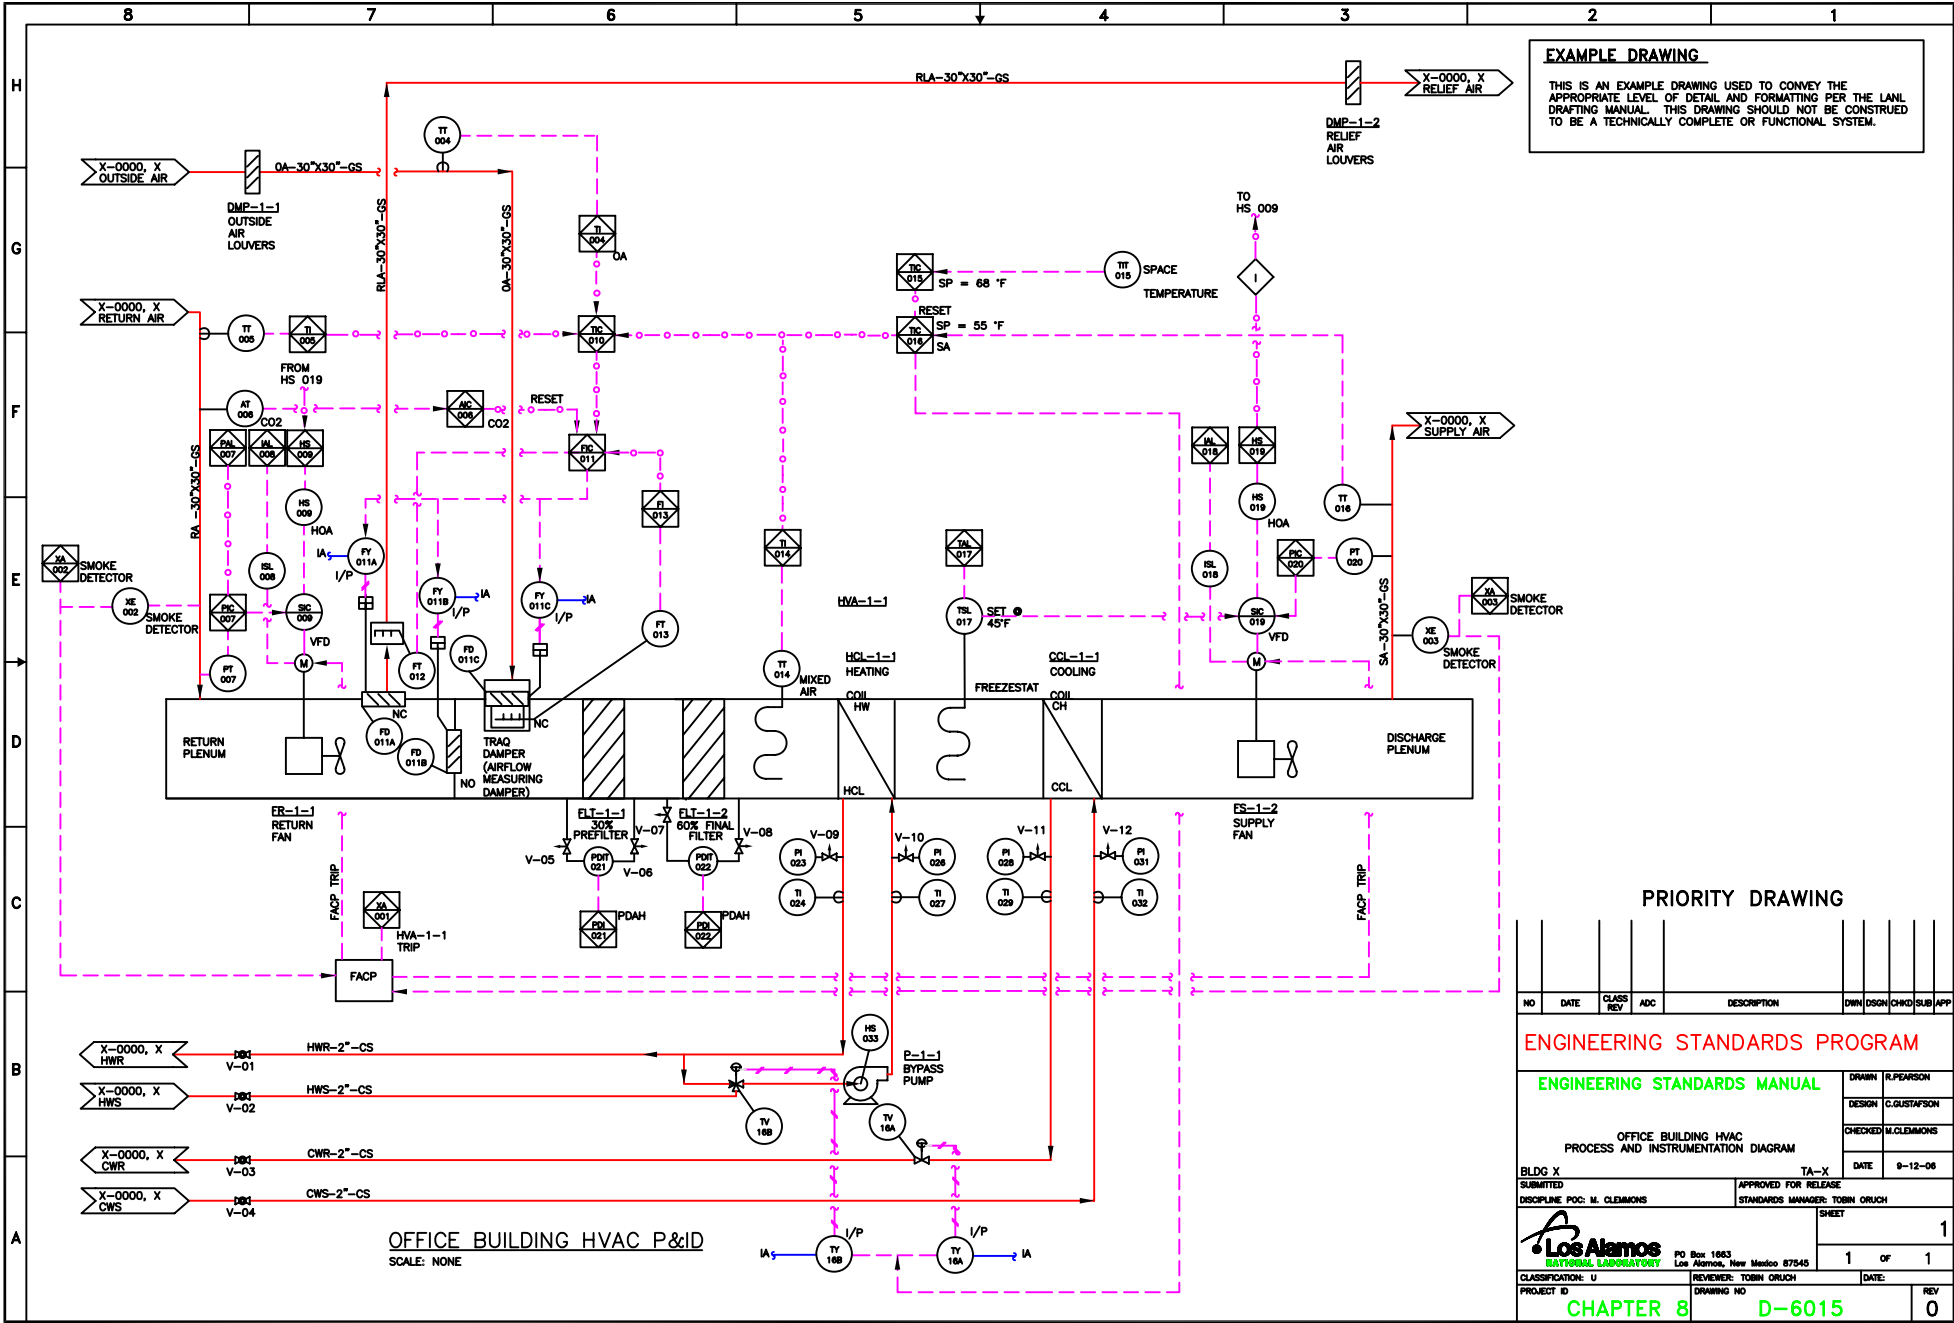

EXAMPLE DRAWING

THIS IS AN EXAMPLE DRAWING USED TO CONVEY THE APPROPRIATE LEVEL OF DETAIL AND FORMATTING PER THE LANT DRAFTING MANUAL. THIS DRAWING SHOULD NOT BE CONSTRUED TO BE A TECHNICALLY COMPLETE OR FUNCTIONAL SYSTEM.

PRIORITY DRAWING

NO	DATE	CLASS REV	ADD	DESCRIPTION	OWN	DSGN	CHKD	SUB	APP
ENGINEERING STANDARDS PROGRAM									
ENGINEERING STANDARDS MANUAL								DESIGN	R. PEARSON
OFFICE BUILDING HVAC PROCESS AND INSTRUMENTATION DIAGRAM								CHECKED	M. CLEMMONS
BLDG X		SUBMITTED		APPROVED FOR RELEASE		DATE		9-12-06	
DISCIPLINE POC: M. CLEMMONS		STANDARDS MANAGER: TOBIN ORUCH		SHEET		1		1	
CLASSIFICATION: U		REVIEWER: TOBIN ORUCH		DATE:		1		1	
PROJECT ID		DRAWING NO		DATE:		1		1	
CHAPTER 8		D-6015		REV		0			